
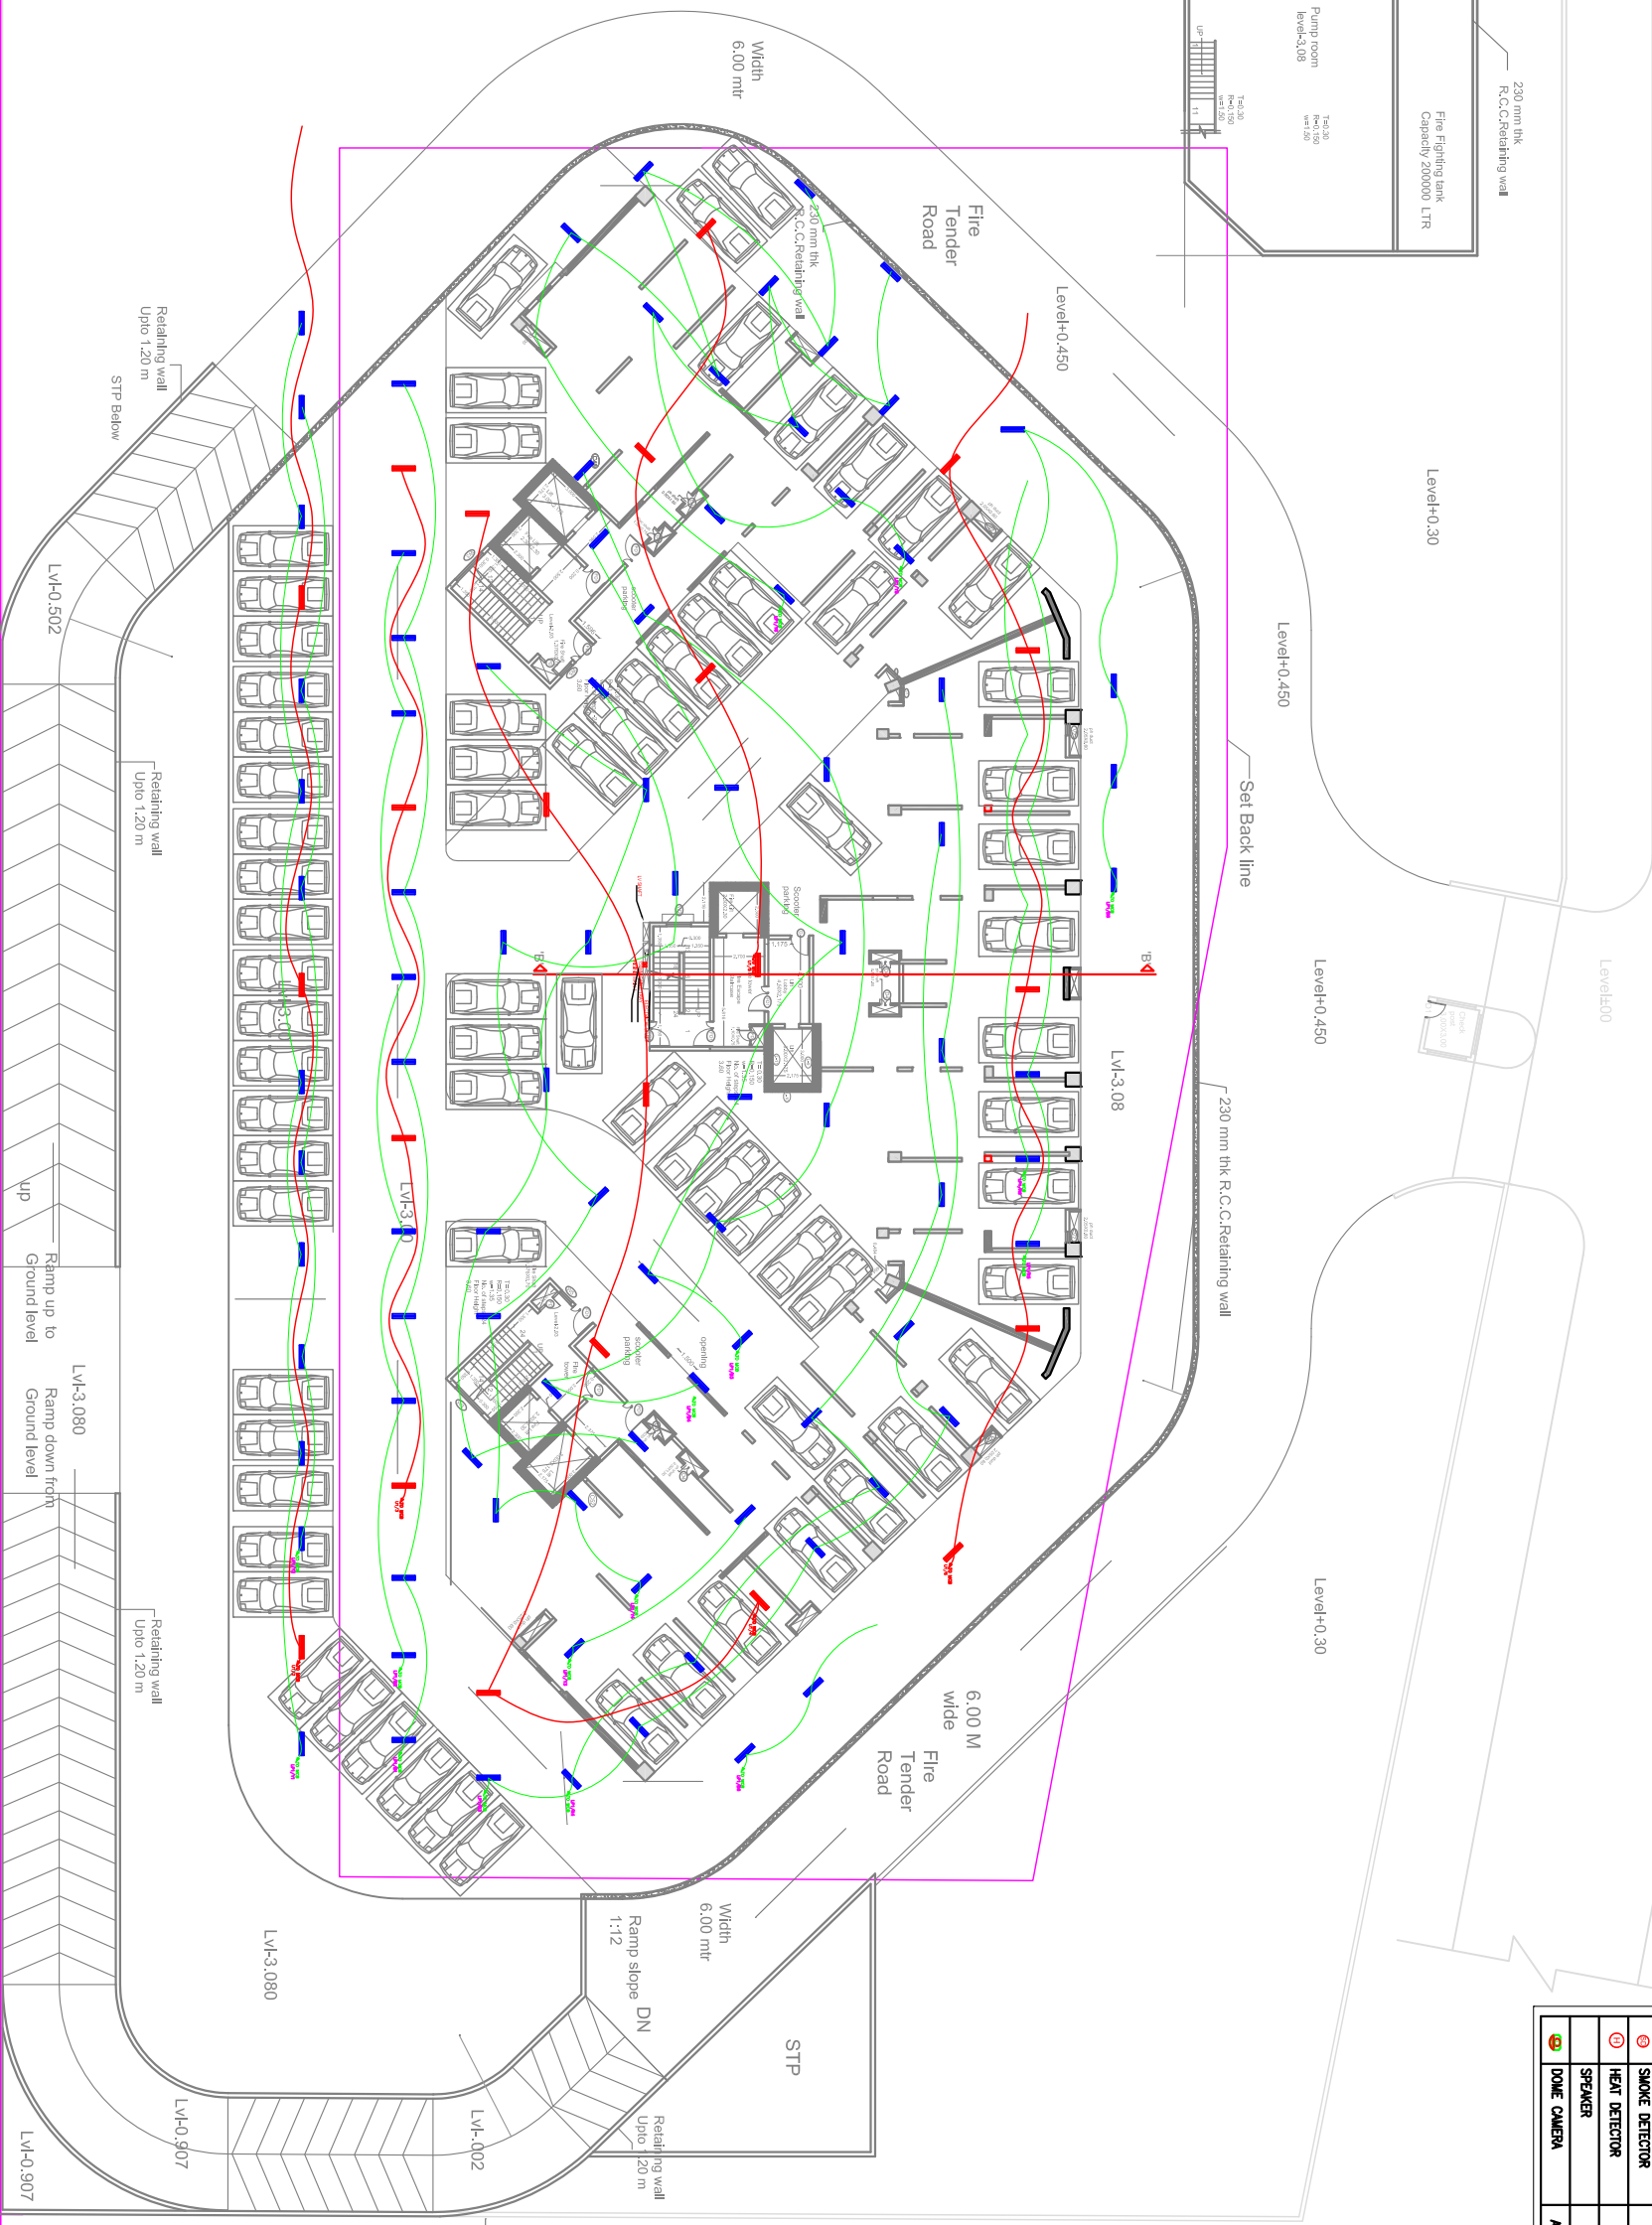


GH-02 area 2.50 Acre

164'-0" / 50 mtr wide road

Green belt 4.57 m wide

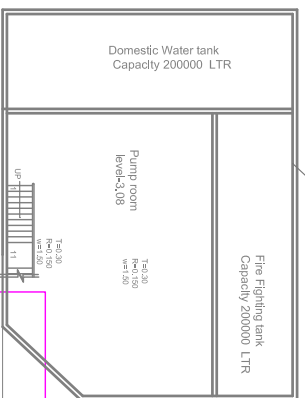

SYMBOL	DESCRIPTION	HEIGHT IN MM
[Symbol]	FIRE ALARM LEGEND--	F.F.L.
[Symbol]	HOTTER CUM STROBE	2100
[Symbol]	MANUAL CALL POINT	1050
[Symbol]	CONTROL MODULE	1050
[Symbol]	TRANSFORMER JACK	1050
[Symbol]	SMOKE DETECTOR	CEILING
[Symbol]	HEAT DETECTOR	CEILING
[Symbol]	SPEAKER	CEILING
[Symbol]	DOME CAMERA	ASPER SITE

SYMBOL	DESCRIPTION	HEIGHT IN MM
[Symbol]	SWITCH OUTLET	1050MM FFL
[Symbol]	2WAY SWITCH OUTLET	1050MM FFL
[Symbol]	EMERGENCY SWITCH OUTLET	1800MM FFL
[Symbol]	FAN REGULATOR	1050MM FFL
[Symbol]	18 WALL LIGHT	2100MM FFL
[Symbol]	10W TABLE LAMP	AS PER SITE
[Symbol]	6W LED LIGHT	CEILING
[Symbol]	12W LED LIGHT	CEILING
[Symbol]	MIRROR LIGHT	ABOVE MIRROR
[Symbol]	CHANDLER	CEILING
[Symbol]	20W LED WALL BATTEN LIGHT	2100MM FFL
[Symbol]	1500MM CEILING FAN	CEILING
[Symbol]	600MM CEILING FAN	CEILING
[Symbol]	18W LED LIGHT	CEILING
[Symbol]	6A LIGHT PLUG	300/1100MM FFL
[Symbol]	6A LIGHT PLUGGED (SRE)	550MM FFL
[Symbol]	6/19A POWER PLUG (KITCHEN)	900MM FFL
[Symbol]	6/19A POWER PLUG (WASHING MACHINE)	900MM FFL
[Symbol]	6/19A POWER PLUG (REFRIGERATOR)	900MM FFL
[Symbol]	2 NOS. 6 AMP SOCKET CONTROLLED BY SWITCH (TOK T.V.)	900MM FFL
[Symbol]	6/19A POWER PLUG	900/100MM FFL
[Symbol]	16A SWITCH SOCKET FOR MICROWAVE OVEN	900MM FFL
[Symbol]	16A SWITCH SOCKET FOR RO	1800MM FFL
[Symbol]	6A SOCKET FOR CHIMNEY	2100MM FFL
[Symbol]	6A SWITCH SOCKET FOR SERVER	1050MM FFL
[Symbol]	20A SOCKET FOR GEYSER	1800MM FFL
[Symbol]	25A SOCKET FOR AC	2100MM FFL
[Symbol]	16A SOCKET FOR HAND DRYER	1100MM FFL
[Symbol]	6A SWITCH SOCKET FOR KITCHEN	900MM FFL
[Symbol]	CEILING ROSE	2100MM FFL
[Symbol]	EXHAUST FAN	2100MM FFL
[Symbol]	BELL BUZZER	1050MM FFL
[Symbol]	BELL PUSH	AS PER SITE
[Symbol]	BULK HEAD LIGHT	550MM FFL
[Symbol]	TELEPHONE OUTLET	900MM FFL
[Symbol]	16A SOCKET FOR LIFT	ASPER SITE
[Symbol]	DATA OUTLET	300MM FFL
[Symbol]	25A SWITCH FOR AC	2100MM FFL
[Symbol]	DISTRIBUTION BOARD	1800MM FFL
[Symbol]	20W LED BATTEN LIGHT	CEILING
[Symbol]	SUB MAIN CONDUIT	CEILING

PROJECT:-

Construction of Multi Storey Flats at GH-1 Eco City, phase -2 (Extension) New Chandigarh

CLIENT:-

EXECUTING AGENCY OR PMC:-

REVISIONS

S.NO.	NOTES	DATE

SHEET TITLE:-

DRG. TITLE:- BASEMENT PLAN ELECTRICAL LAYOUT

DEALT BY:-

NAVJEET

CHKD BY:-

S.K

DATE:-

11-03-2023

DRG. NO.:-

SCALE :- NTS

SDBASEMENT/EL-01

REVISION :-

CLIENT:-

P.M.C.-

ARCHITECT:-

Renu Khanna & Associates
architects, engineers,interiors and landscape planners

Unit No. 103, Sector 37B
Phase 1, Gurgaon, Haryana
Pin: 122002
Ph: 0172-2383379

M: 98972627180, fax: 01722694538
Email: renukhannaarchitect@yahoo.com

Web: architectsrinkhanna.com

Parking Plan at level -3.08

C.L.U. already Granted

1.83 m High Boundary wall

1.83 m High Boundary wall


1.83 m High Boundary wall

1.83 m High Boundary wall

1.83 m High Boundary wall

1.83 m High Boundary wall

GH-02 area 2.50 Acre

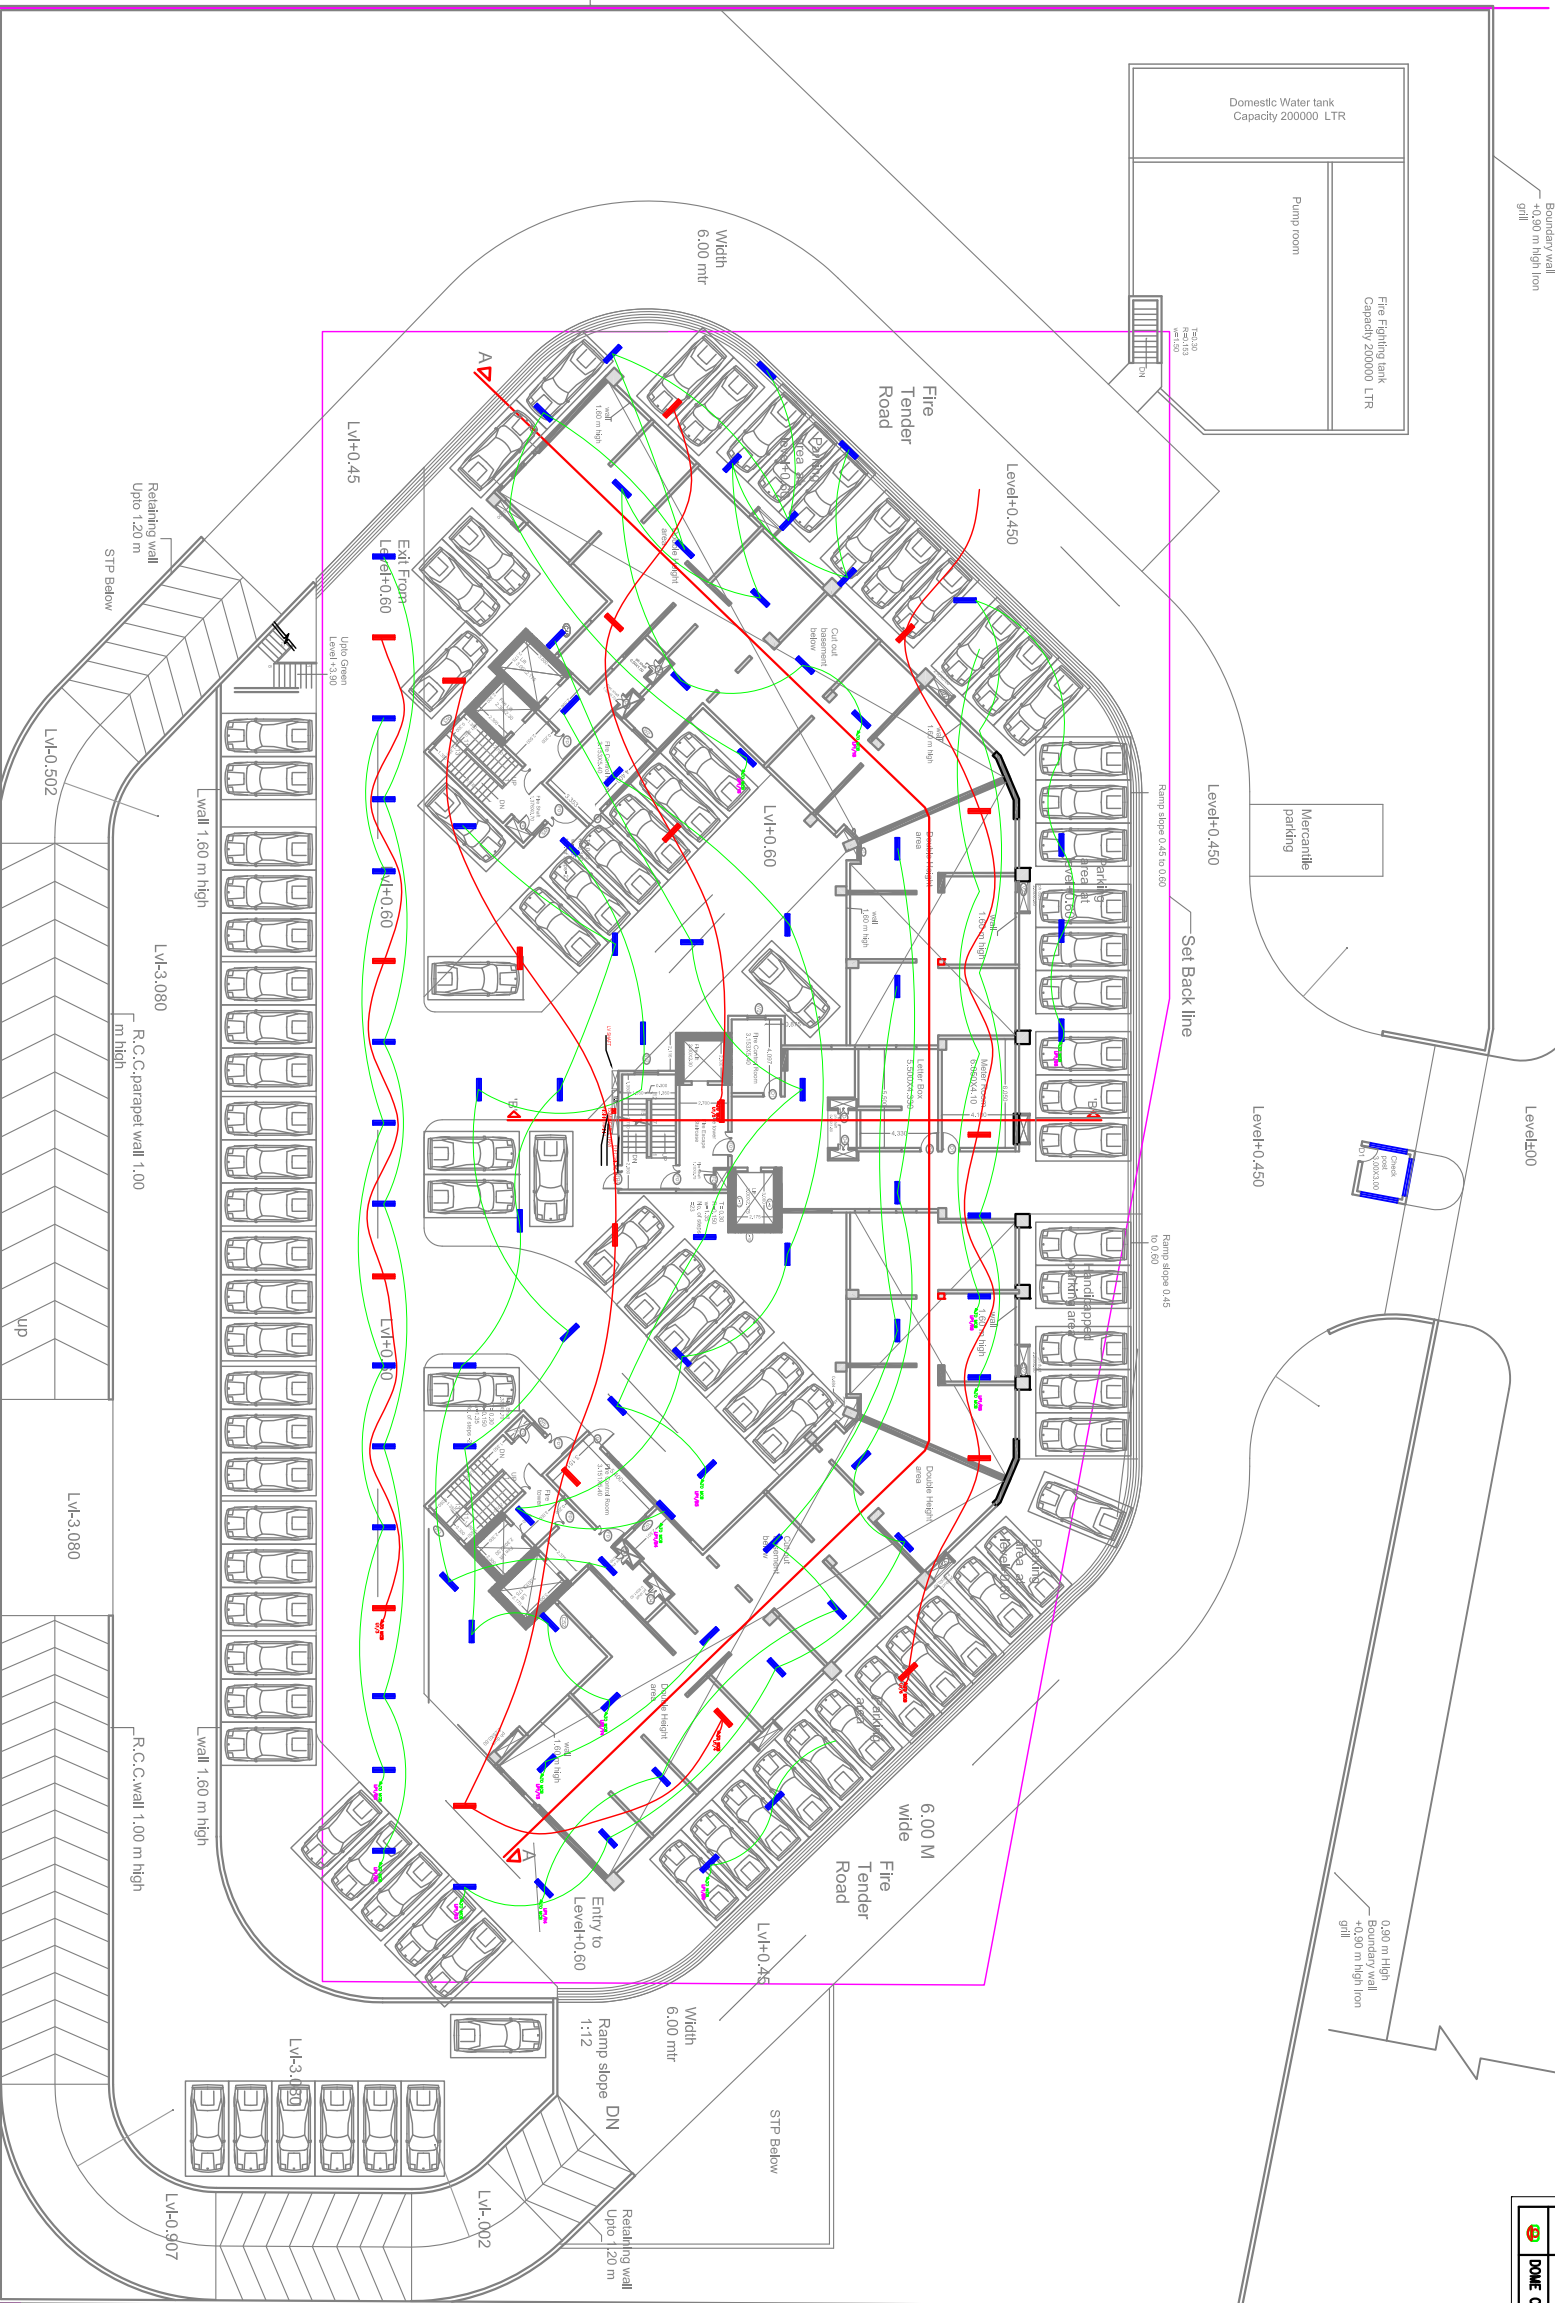

Stillt Parking Plan at level +0.60M

C.L.U. already Granted

SYMBOL	DESCRIPTION	HEIGHT FROM F.F.L.
[Symbol]	FIRE ALARM LEGEND-	
[Symbol]	HOOPER CUM STROBE	2100
[Symbol]	MANUAL CALL POINT	1050
[Symbol]	CONTROL MODULE	1050
[Symbol]	TRANSPHONE JACK	1050
[Symbol]	EXT SMOKE	CEILING
[Symbol]	SMOKE DETECTOR	CEILING
[Symbol]	HEAT DETECTOR	CEILING
[Symbol]	SPEAKER	CEILING
[Symbol]	DMK CAMERA	ASPER SITE

SYMBOL	DESCRIPTION	HEIGHT IN MM
[Symbol]	SWITCH OUTLET	1050MM FFL
[Symbol]	2WAY SWITCH OUTLET	1050MM FFL
[Symbol]	EMERGENCY SWITCH OUTLET	1800MM FFL
[Symbol]	FAN REGULATOR	1050MM FFL
[Symbol]	18 WALL LIGHT	2100MM FFL
[Symbol]	10W TABLE LAMP	AS PER SITE
[Symbol]	2W LED LIGHT	CEILING
[Symbol]	12W LED LIGHT	CEILING
[Symbol]	MIRROR LIGHT	ABOVE MIRROR
[Symbol]	CHANDELIER	CEILING
[Symbol]	20W LED WALL BATTEN LIGHT	2100MM FFL
[Symbol]	1200MM CEILING FAN	CEILING
[Symbol]	900MM CEILING FAN	CEILING
[Symbol]	18W LED LIGHT	CEILING
[Symbol]	8A LIGHT PLUG	300/1100MM FFL
[Symbol]	8A LIGHT PLUG (EJED SIDE)	550MM FFL
[Symbol]	8/16A POWER PLUG (KITC/DEN)	900MM FFL
[Symbol]	8/16A POWER PLUG (WASHING MACHINE)	900MM FFL
[Symbol]	8/16A POWER PLUG (REFRIGERATOR)	900MM FFL
[Symbol]	2 NOS. 6 AMP SOCKET CONTROLLED BY 2 NOS. 6 AMP SWITCH (KITC/DEN)	900MM FFL
[Symbol]	8/16A POWER PLUG	900/1050MM FFL
[Symbol]	18A SWITCH SOCKET FOR MICROWAVE OVEN	900MM FFL
[Symbol]	18A SWITCH SOCKET FOR RO	1800MM FFL
[Symbol]	8A SOCKET FOR CHIMNEY	1050MM FFL
[Symbol]	8A SWITCH SOCKET FOR SETTER	1800MM FFL
[Symbol]	25A SOCKET FOR GEYSER	1800MM FFL
[Symbol]	25A SOCKET FOR AC	2100MM FFL
[Symbol]	18A SOCKET FOR HAND DRYER	1100MM FFL
[Symbol]	8A SWITCH SOCKET FOR MITCHEN	900MM FFL
[Symbol]	CEILING ROSE	2100MM FFL
[Symbol]	EXHAUST FAN	2100MM FFL
[Symbol]	BELL BUZZER	2100MM FFL
[Symbol]	BELL PUSH	1050MM FFL
[Symbol]	BULK HEAD LIGHT	AS PER SITE
[Symbol]	TELEPHONE OUTLET	550MM FFL
[Symbol]	TELEVISION OUTLET	900MM FFL
[Symbol]	18A SOCKET FOR LUFT	ASPER SITE
[Symbol]	DATA OUTLET	300MM FFL
[Symbol]	25A SWITCH FOR AC	2100MM FFL
[Symbol]	DISTRIBUTION BOARD	1800MM FFL
[Symbol]	20W LED BATTENLIGHT	CEILING
[Symbol]	SUB MAIN CONCURIT	CEILING

PROJECT:-

Construction of Multi Storey Flats
at GH-1 Eco City, phase -2
(Extension) New Chandigangh

CLIENT:-

EXECUTING AGENCY OR PMC:-

REVISIONS

S.NO.	NOTES	DATE
-------	-------	------

SHEET TITLE:-

**DRG. TITLE:- STILLT PLAN
ELECTRICAL LAYOUT**

DEALT BY:-	NAVINEET
CHKD BY:-	S.K
DATE:-	11-03-2023
DRG. NO. :-	SCALE :- NTS
SDBASEMENT/EL-01	REVISION :-

CLIENT:- P.M.C:-



ARCHITECT:-

Renu Khanna & Associates
architects, engineers,interiors and
landscape planners
offices:138, sec.-10 panchkula
Ph: 0172 - 2563379
M: 09872627180, fax: 01725684538
Email: renukhanna.architect@gmail.com
renukhanna.architect@yahoo.com
Web: architectstrenukhanna.com

Park 1.47 acre

164'-0" / 50 mtr wide road

Green belt: 4.57 m wide

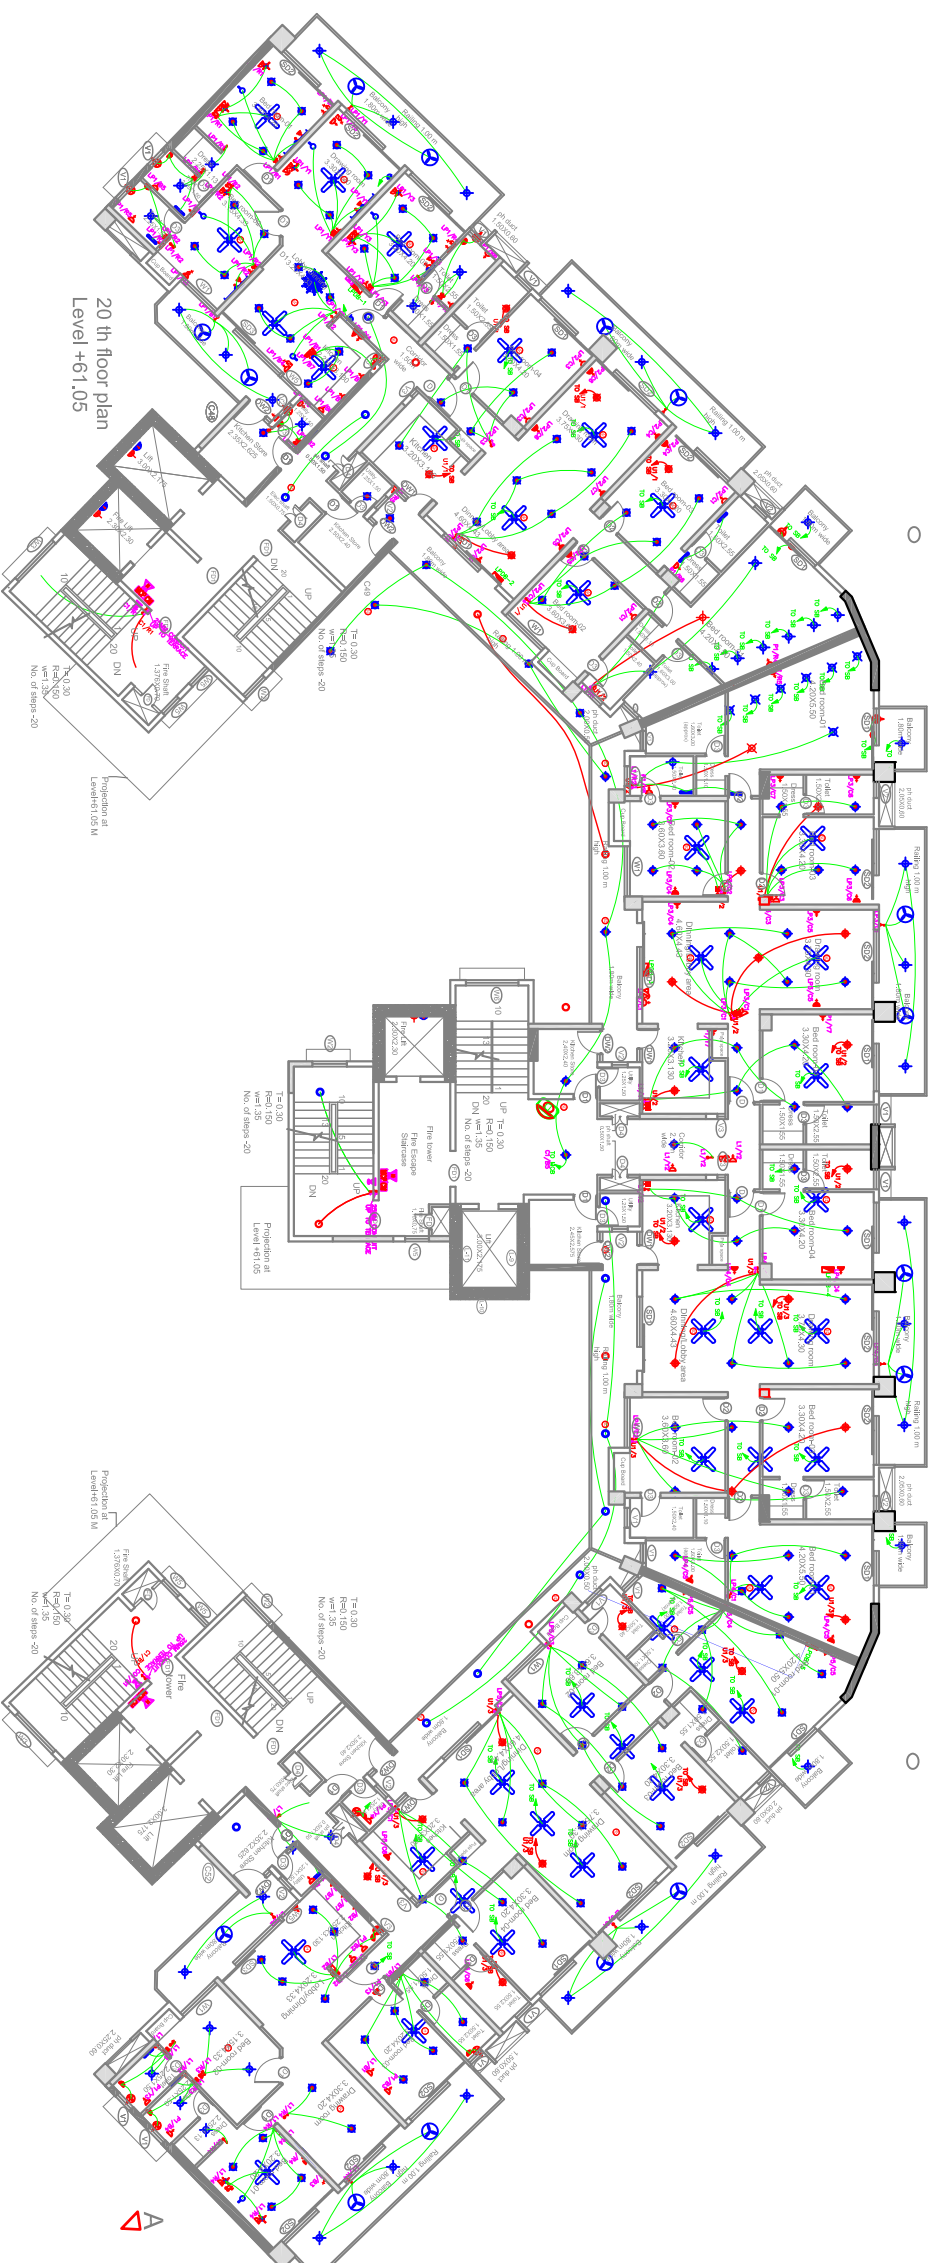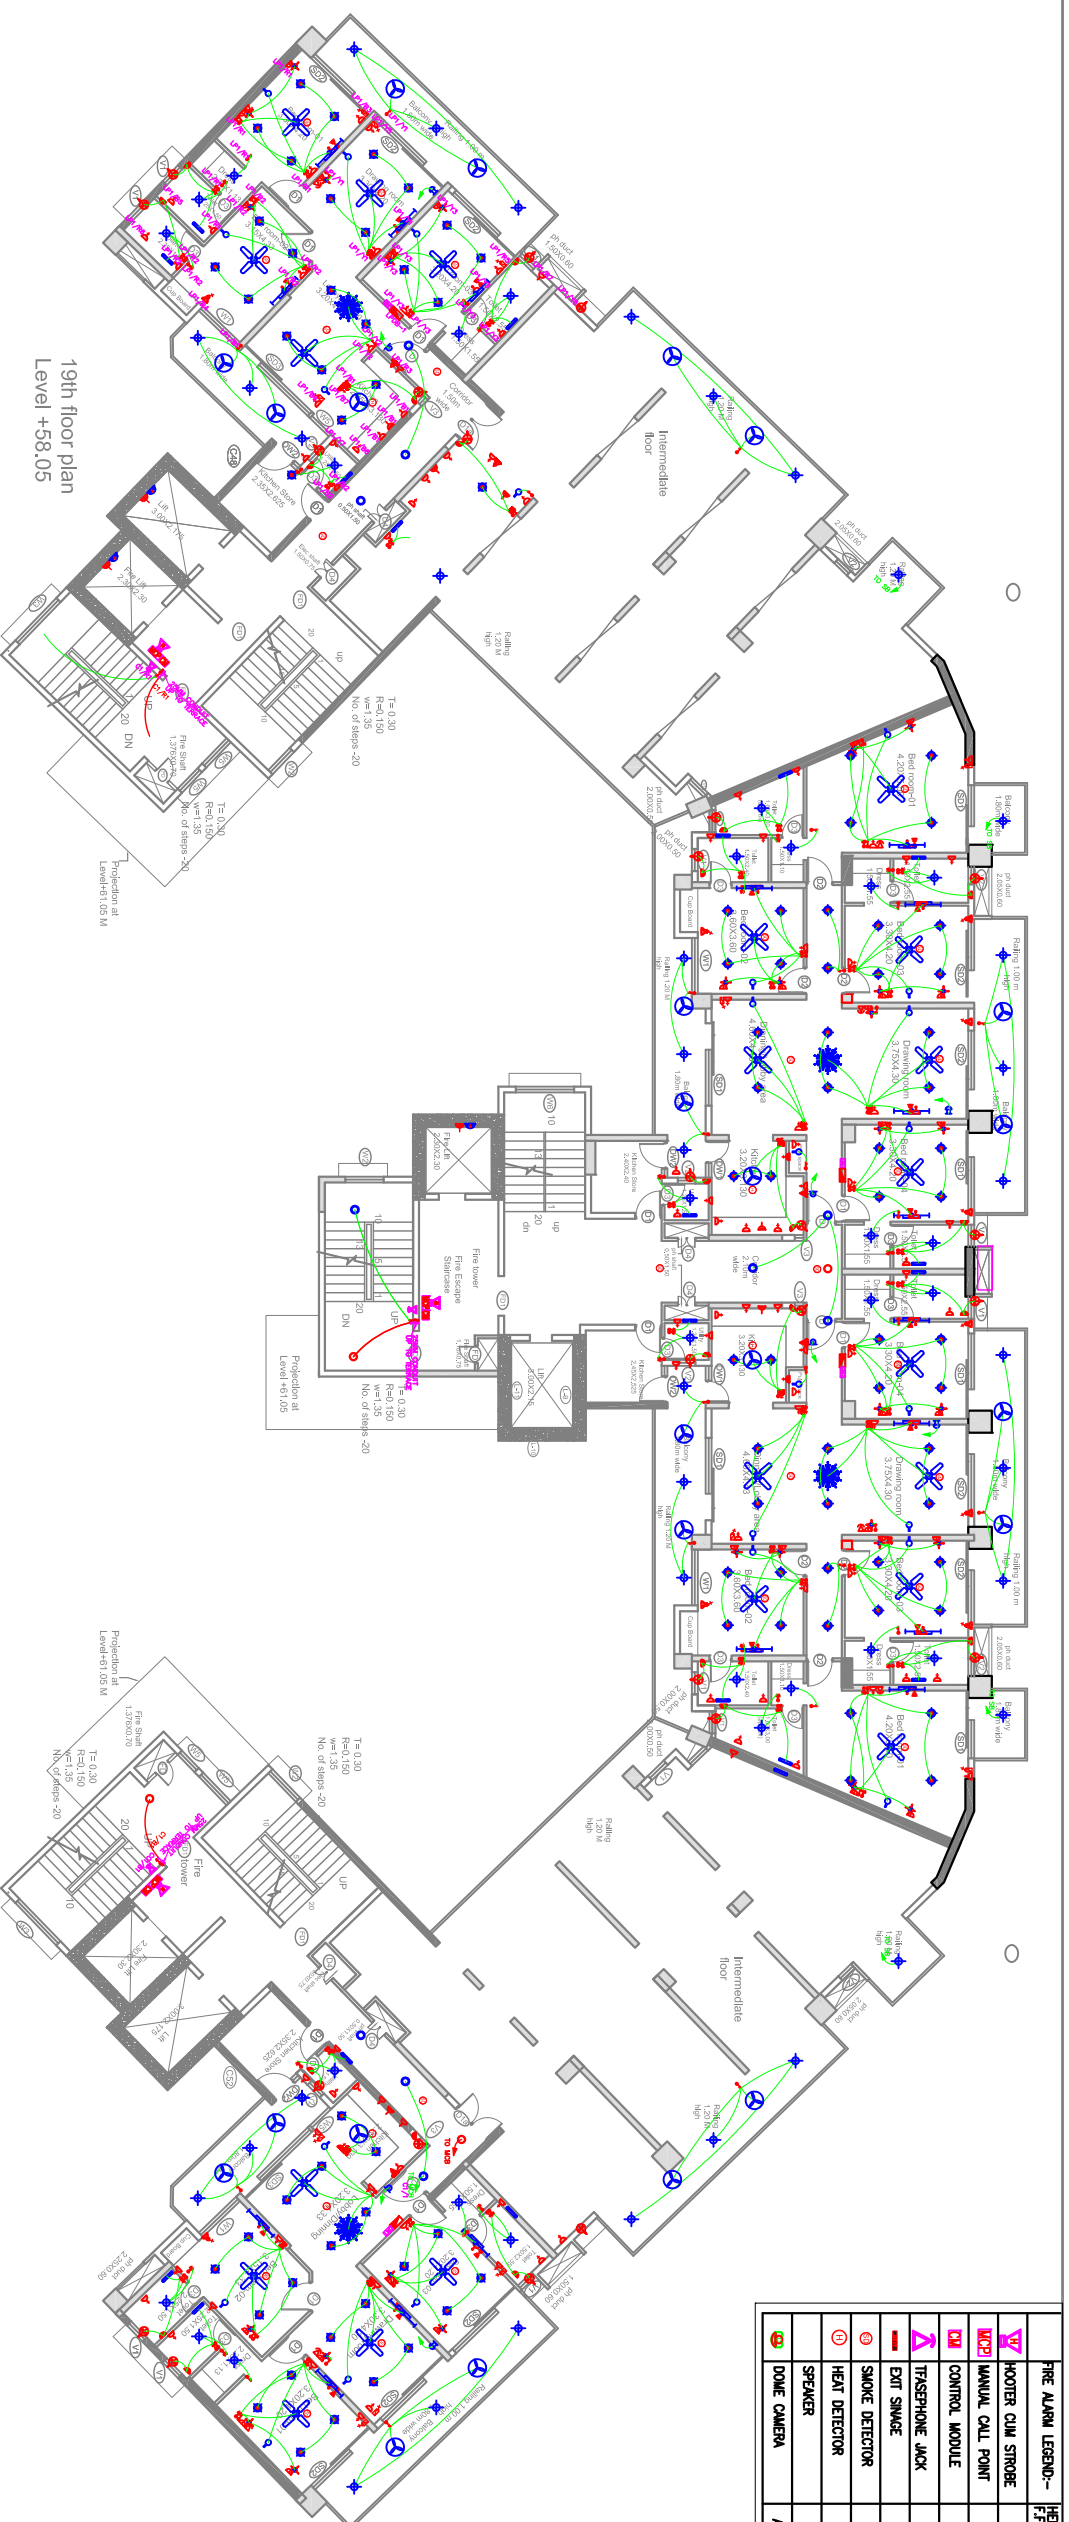

SYMBOL	DESCRIPTION	HEIGHT FROM F.F.L.
🔥	FIRE ALARM LEGEND	
🔊	HOOPER CUM STROBE	2100
📞	MANUAL CALL POINT	1050
🔧	CONTROL MODULE	1050
📞	TELEPHONE JACK	1050
🔥	EXIT SMOKE	CEILING
🔥	SMOKE DETECTOR	CEILING
🔥	HEAT DETECTOR	CEILING
🔊	SPEAKER	CEILING
📹	DOME CAMERA	ASPER SITE

SYMBOL	DESCRIPTION	HEIGHT FROM F.F.L.
🔊	HOOPER CUM STROBE	2100MM FFL
📞	MANUAL CALL POINT	1050MM FFL
🔧	CONTROL MODULE	1050MM FFL
📞	TELEPHONE JACK	1050MM FFL
🔥	EXIT SMOKE	1050MM FFL
🔥	SMOKE DETECTOR	1050MM FFL
🔥	HEAT DETECTOR	1050MM FFL
🔊	SPEAKER	1050MM FFL
📹	DOME CAMERA	ASPER SITE
🔊	HOOPER CUM STROBE	2100MM FFL
📞	MANUAL CALL POINT	1050MM FFL
🔧	CONTROL MODULE	1050MM FFL
📞	TELEPHONE JACK	1050MM FFL
🔥	EXIT SMOKE	1050MM FFL
🔥	SMOKE DETECTOR	1050MM FFL
🔥	HEAT DETECTOR	1050MM FFL
🔊	SPEAKER	1050MM FFL
📹	DOME CAMERA	ASPER SITE
🔊	HOOPER CUM STROBE	2100MM FFL
📞	MANUAL CALL POINT	1050MM FFL
🔧	CONTROL MODULE	1050MM FFL
📞	TELEPHONE JACK	1050MM FFL
🔥	EXIT SMOKE	1050MM FFL
🔥	SMOKE DETECTOR	1050MM FFL
🔥	HEAT DETECTOR	1050MM FFL
🔊	SPEAKER	1050MM FFL
📹	DOME CAMERA	ASPER SITE

PROJECT:-

Construction of Multi Storey Flats at GH-1 Eco City, phase -2 (Extension) New Chandigarh

CLIENT:-

EXECUTING AGENCY OR PMC:-

SNO.	REVISIONS	DATE

SHEET TITLE:-


DRG TITLE:-
19TH & 20th FLOOR PLAN ELECTRICAL LAYOUT

DEALT BY:-	NAVEET
CHKD BY:-	S.K
DATE:-	11-03-2023
DRG.NO.:-	SCALE :- NTS
SD/19_29, /EL-03	REVISION :-

CLIENT:-	P.M.C.-
----------	---------

ARCHITECT:-

Renu Khanna & Associates
architects, engineers, interiors and landscape planners
offices: 136, sec-10, jandalka
Ph: 0172 - 2963379
M: 09872627180, fax: 01722964538
Email: renukhanna.architects@gmail.com
Web: architectrenukhanna.com

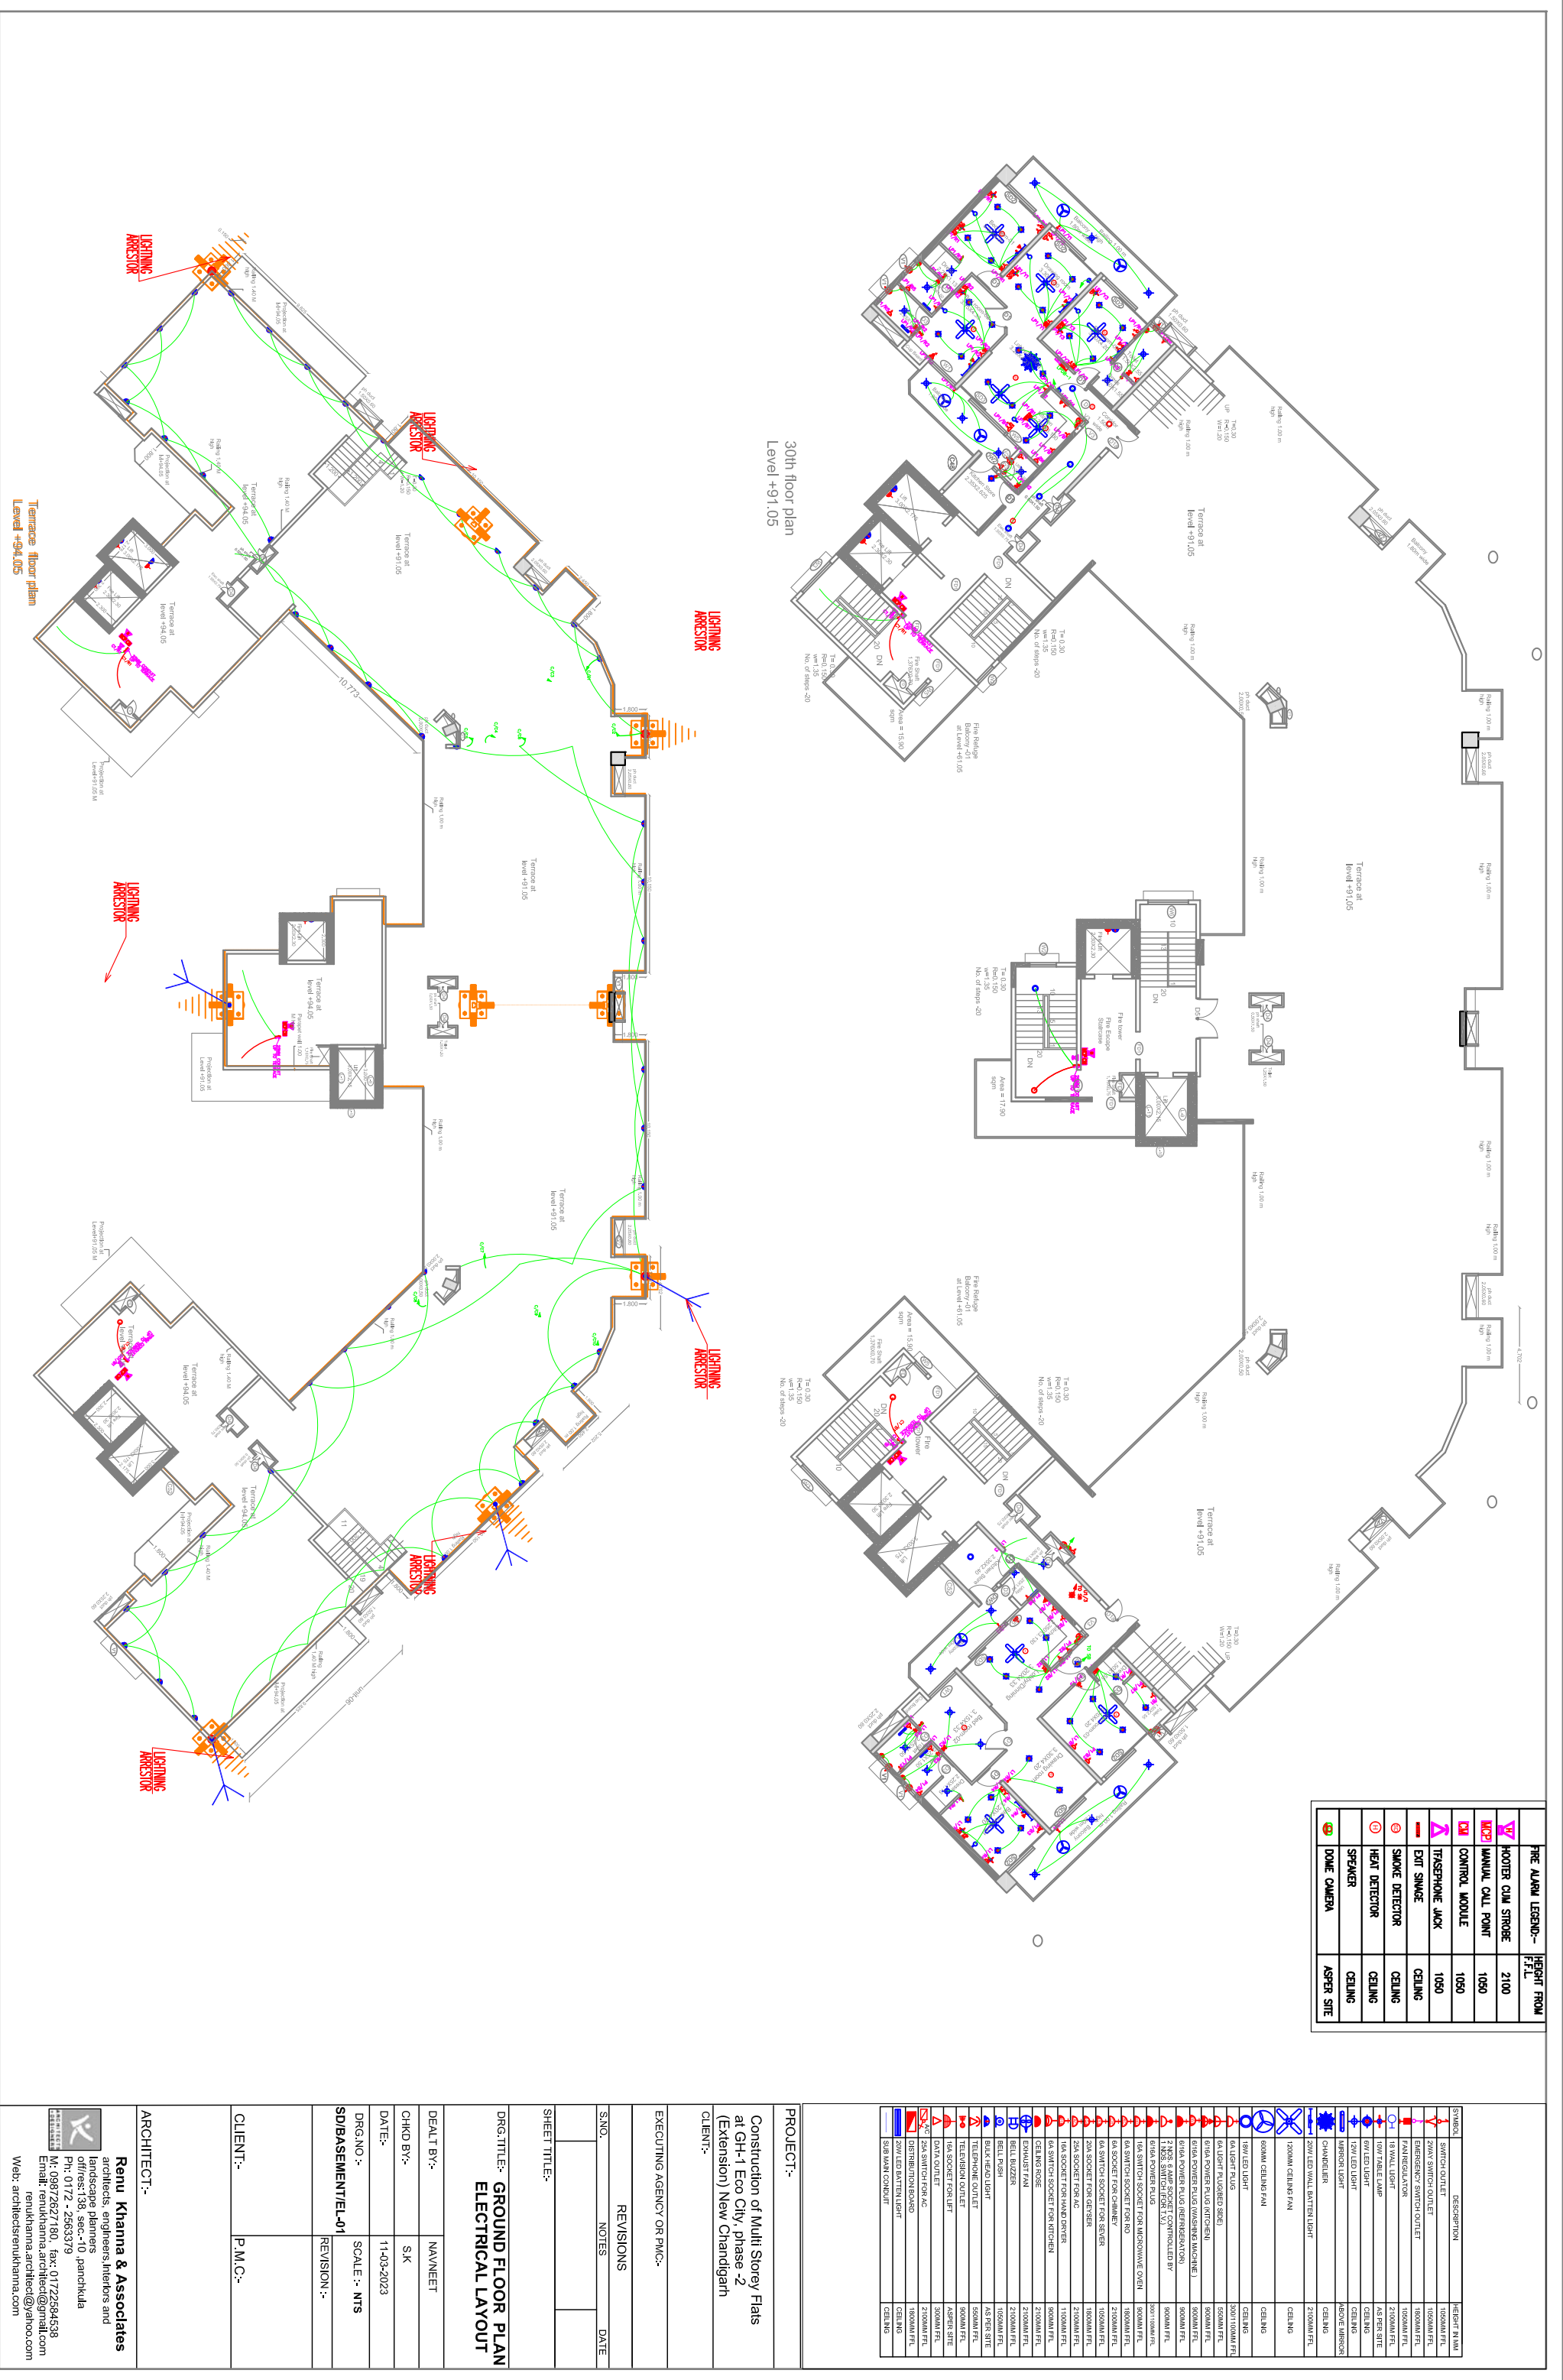

30th floor plan
Level +91.05

Lighting Arrestor

FIRE ALARM LEGEND:-

SYMBOL	DESCRIPTION	HEIGHT FROM F.F.L.
🔥	FIRE ALARM HOOPER	2100
📞	MANUAL CALL POINT	1050
🔌	CONTROL MODULE	1050
🔌	TYPESPHONE JACK	1050
🚪	EXIT SIGNAGE	CEILING
🚬	SMOKE DETECTOR	CEILING
🔊	HEAT DETECTOR	CEILING
🔊	SPEAKER	CEILING
📹	DMIC CAMERA	ASPER SITE

SYMBOL	DESCRIPTION	HEIGHT FROM F.F.L.
🔌	SWITCH OUTLET	1050MM FFL
🔌	2WAY SWITCH OUTLET	1050MM FFL
🔌	EMERGENCY SWITCH OUTLET	1050MM FFL
🔌	PANEL/VALVATOR	1050MM FFL
🔌	18 WALL LIGHT	2100MM FFL
🔌	18 WALL LAMP	AS PER SITE
🔌	18W LED LIGHT	CEILING
🔌	24W LED LIGHT	CEILING
🔌	HARBOR LIGHT	ABOVE WINDOW
🔌	CHANNELER	CEILING
🔌	24W LED WALL BATTEN LIGHT	2100MM FFL
🔌	1000MM CEILING FAN	CEILING
🔌	600MM CEILING FAN	CEILING
🔌	18W LED LIGHT	CEILING
🔌	60W LIGHT FLUORESCED	30001050MM FFL
🔌	60W LIGHT FLUORESCED (DIR)	3000MM FFL
🔌	60W POWER PLUG (WARNING MACHINE)	3000MM FFL
🔌	60W POWER PLUG (REFRIGERATOR)	3000MM FFL
🔌	2 NOS 5 AMP SOCKET CONTROLLED BY	30001050MM FFL
🔌	6A SWITCH SOCKET FOR AIRCOWOME OVEN	3000MM FFL
🔌	6A SWITCH SOCKET FOR NO	1800MM FFL
🔌	6A SOCKET FOR CHIMNEY	2100MM FFL
🔌	6A SOCKET SOCKET FOR SENSER	1800MM FFL
🔌	25A SOCKET FOR GENSER	1100MM FFL
🔌	6A SOCKET FOR HAND DRYER	3000MM FFL
🔌	6A SWITCH SOCKET FOR KITCHEN	2100MM FFL
🔌	CEILING ROSE	2100MM FFL
🔌	BELL BUZZER	2100MM FFL
🔌	BELL HEAD LIGHT	1050MM FFL
🔌	BULK HEAD LIGHT	AS PER SITE
🔌	TELEPHONE OUTLET	300MM FFL
🔌	DATA OUTLET	300MM FFL
🔌	25A SWITCH FOR AC	2100MM FFL
🔌	DISTRIBUTION BOARD	2100MM FFL
🔌	24W LED BATTEN LIGHT	CEILING
🔌	20W LED BATTEN LIGHT	CEILING
🔌	20W LED WALL LIGHT	CEILING
🔌	SUB MAIN CONDUIT	CEILING

PROJECT:-

Construction of Multi Storey Flats
at GH-1 Eco City, phase -2
(Extension) New Chandigarh

CLIENT:-

EXECUTING AGENCY OR PMC:-

REVISIONS

S.NO.	NOTES	DATE

SHEET TITLE:-

DRG. TITLE:- GROUND FLOOR PLAN
ELECTRICAL LAYOUT

DEALT BY:-

NAVNEET

CHKD BY:-

S.K

DATE:-

11-03-2023

DRG. NO.:-

SCALE :- NTS

SD/BASEMENT/EL-01

REVISION :-

CLIENT:-

P.M.C.-

ARCHITECT:-

Renu Khanna & Associates
architects, engineers, interiors and
landscape planners
offices: 136, sec.-10, panchkula
Ph: 0172 - 2963379
M: 09872627180, fax: 01722684538
Email: renukhanna.architect@gmail.com
renukhanna.architect@yahoo.com
Web: architectstrenukhanna.com